


REVISIONS			
ZONE	REV	DATE	APPROVED

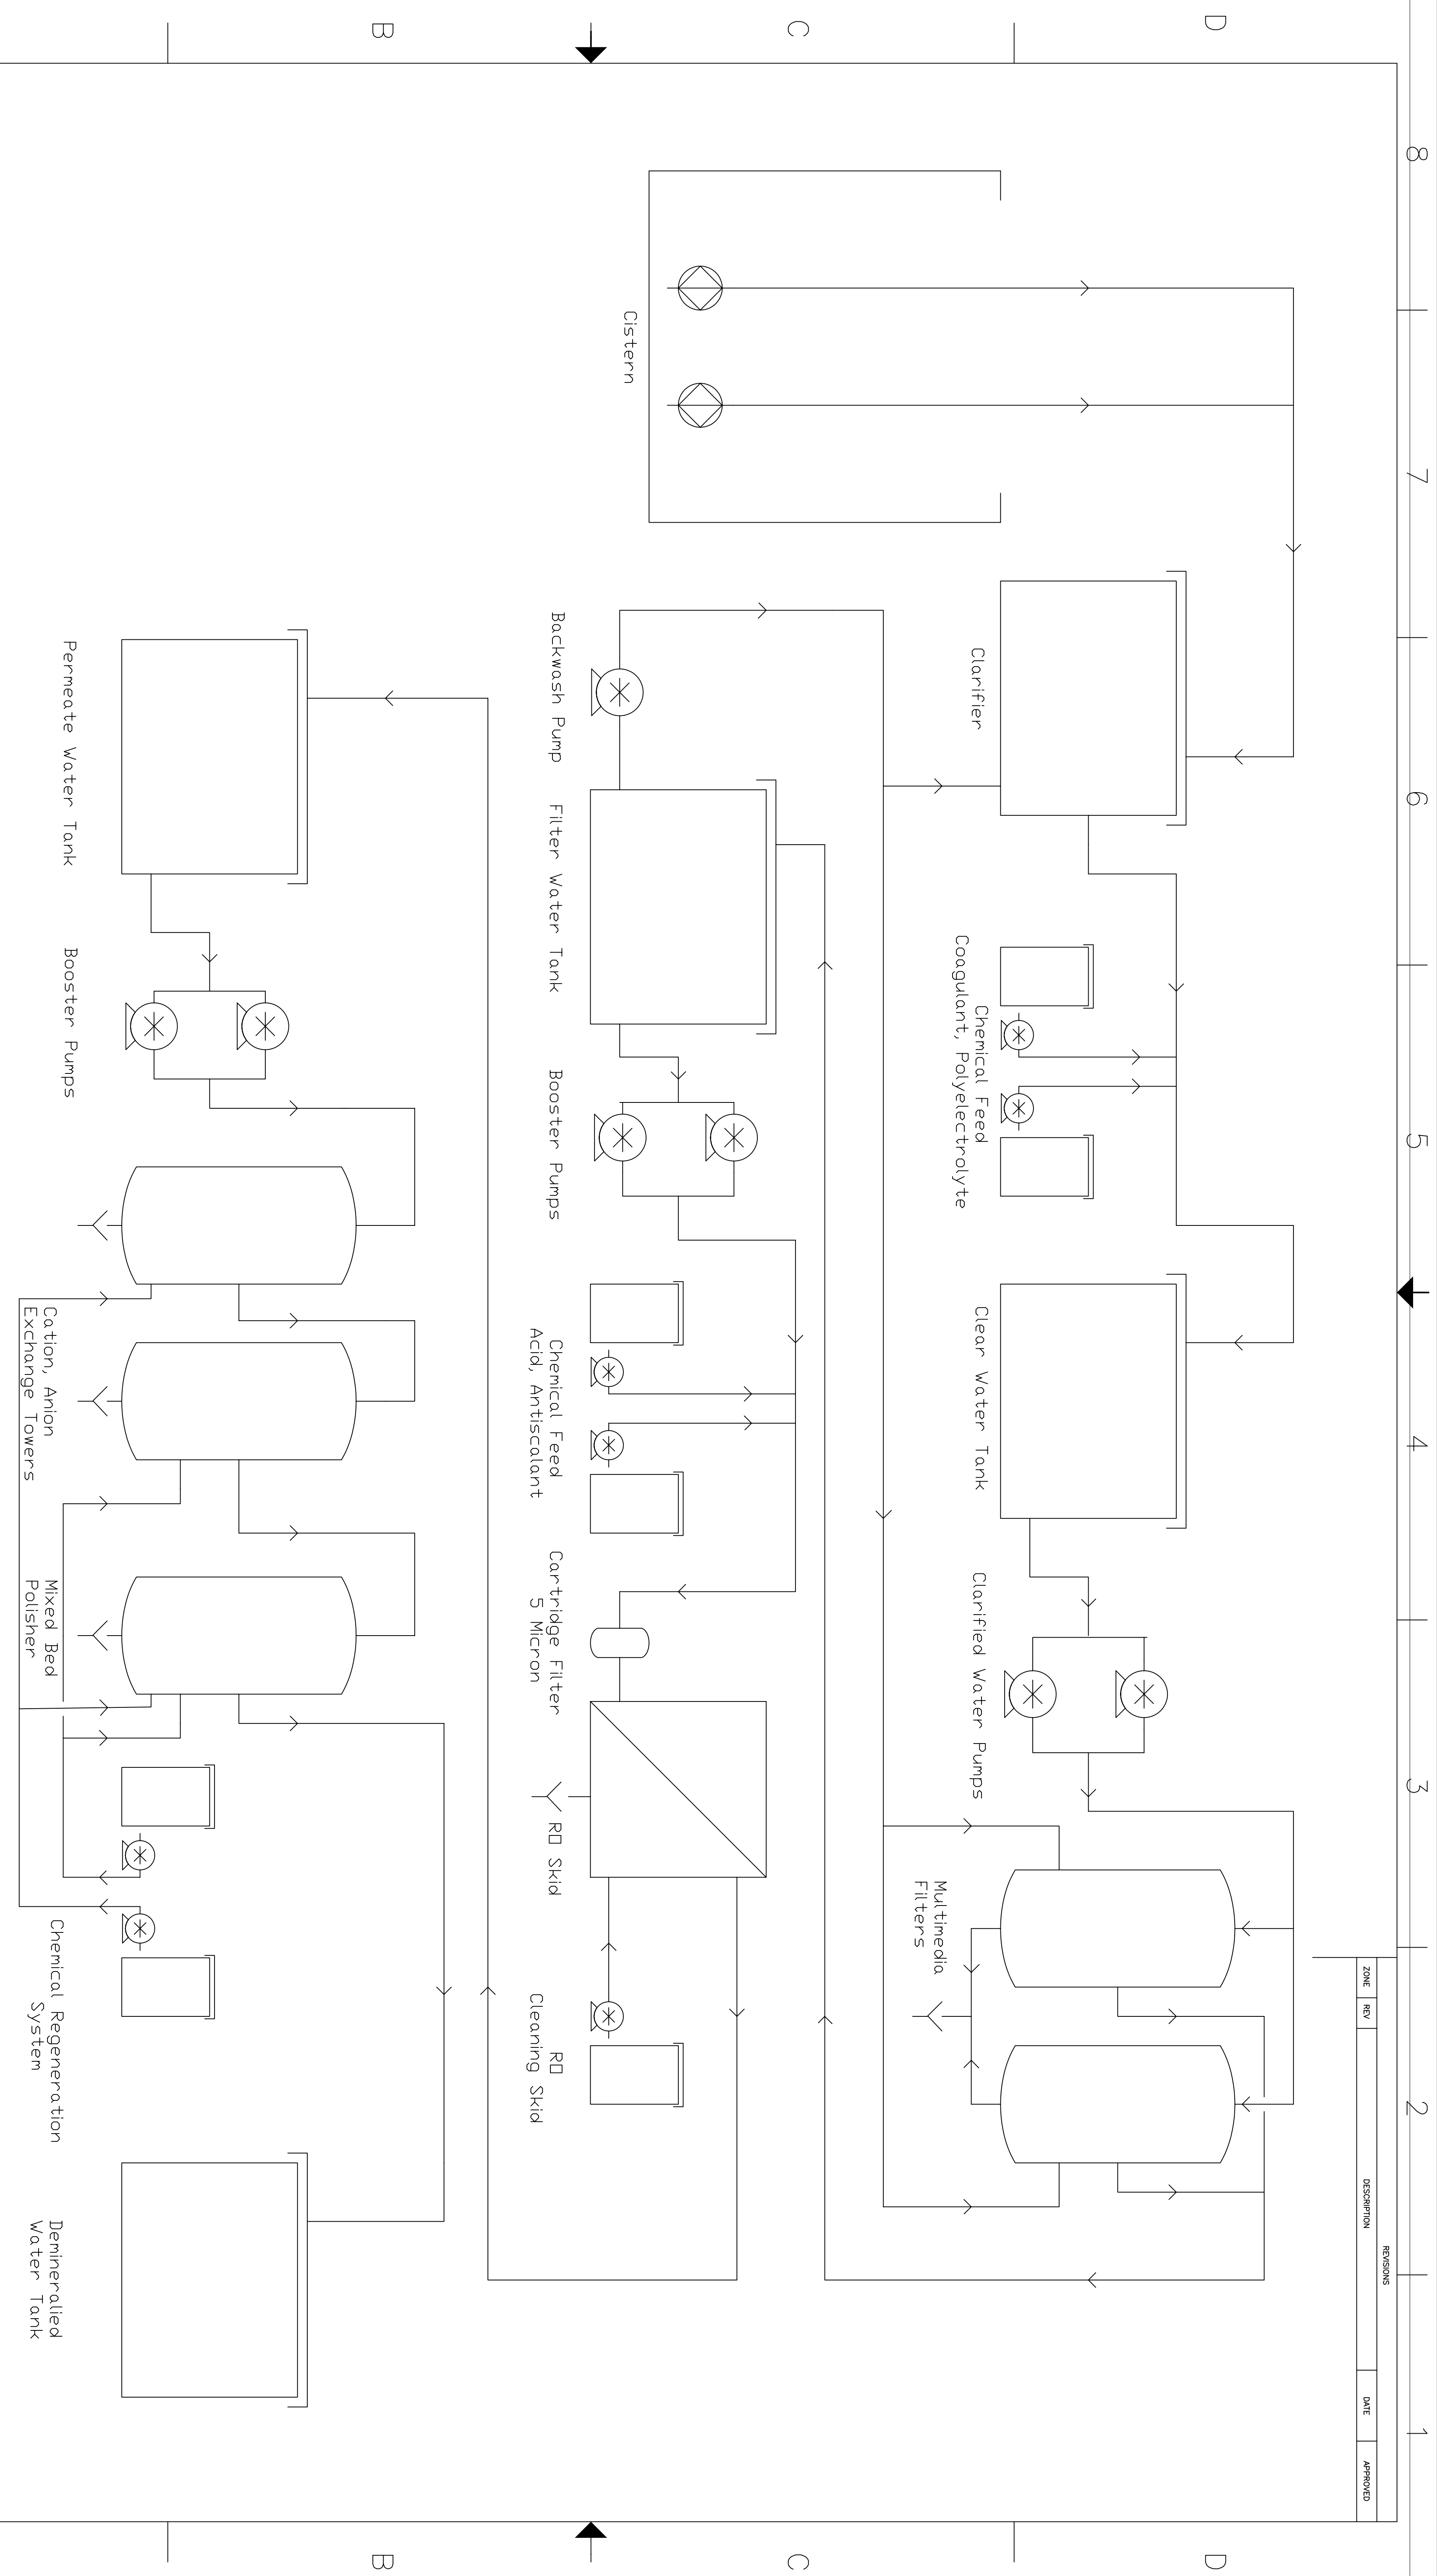

Water Professionals
 The Water Professionals
 212 Cooper Ln,
 Boksburg 2012
 www.waterprofessionals.biz

Process Flow Diagram

SIZE: F50W NO. DWG NO. Sample

SCALE: NTS SHEET: 1/1

19 Sept 06 REV: -